


Design Portfolio

ARC5039


By Maha Miah

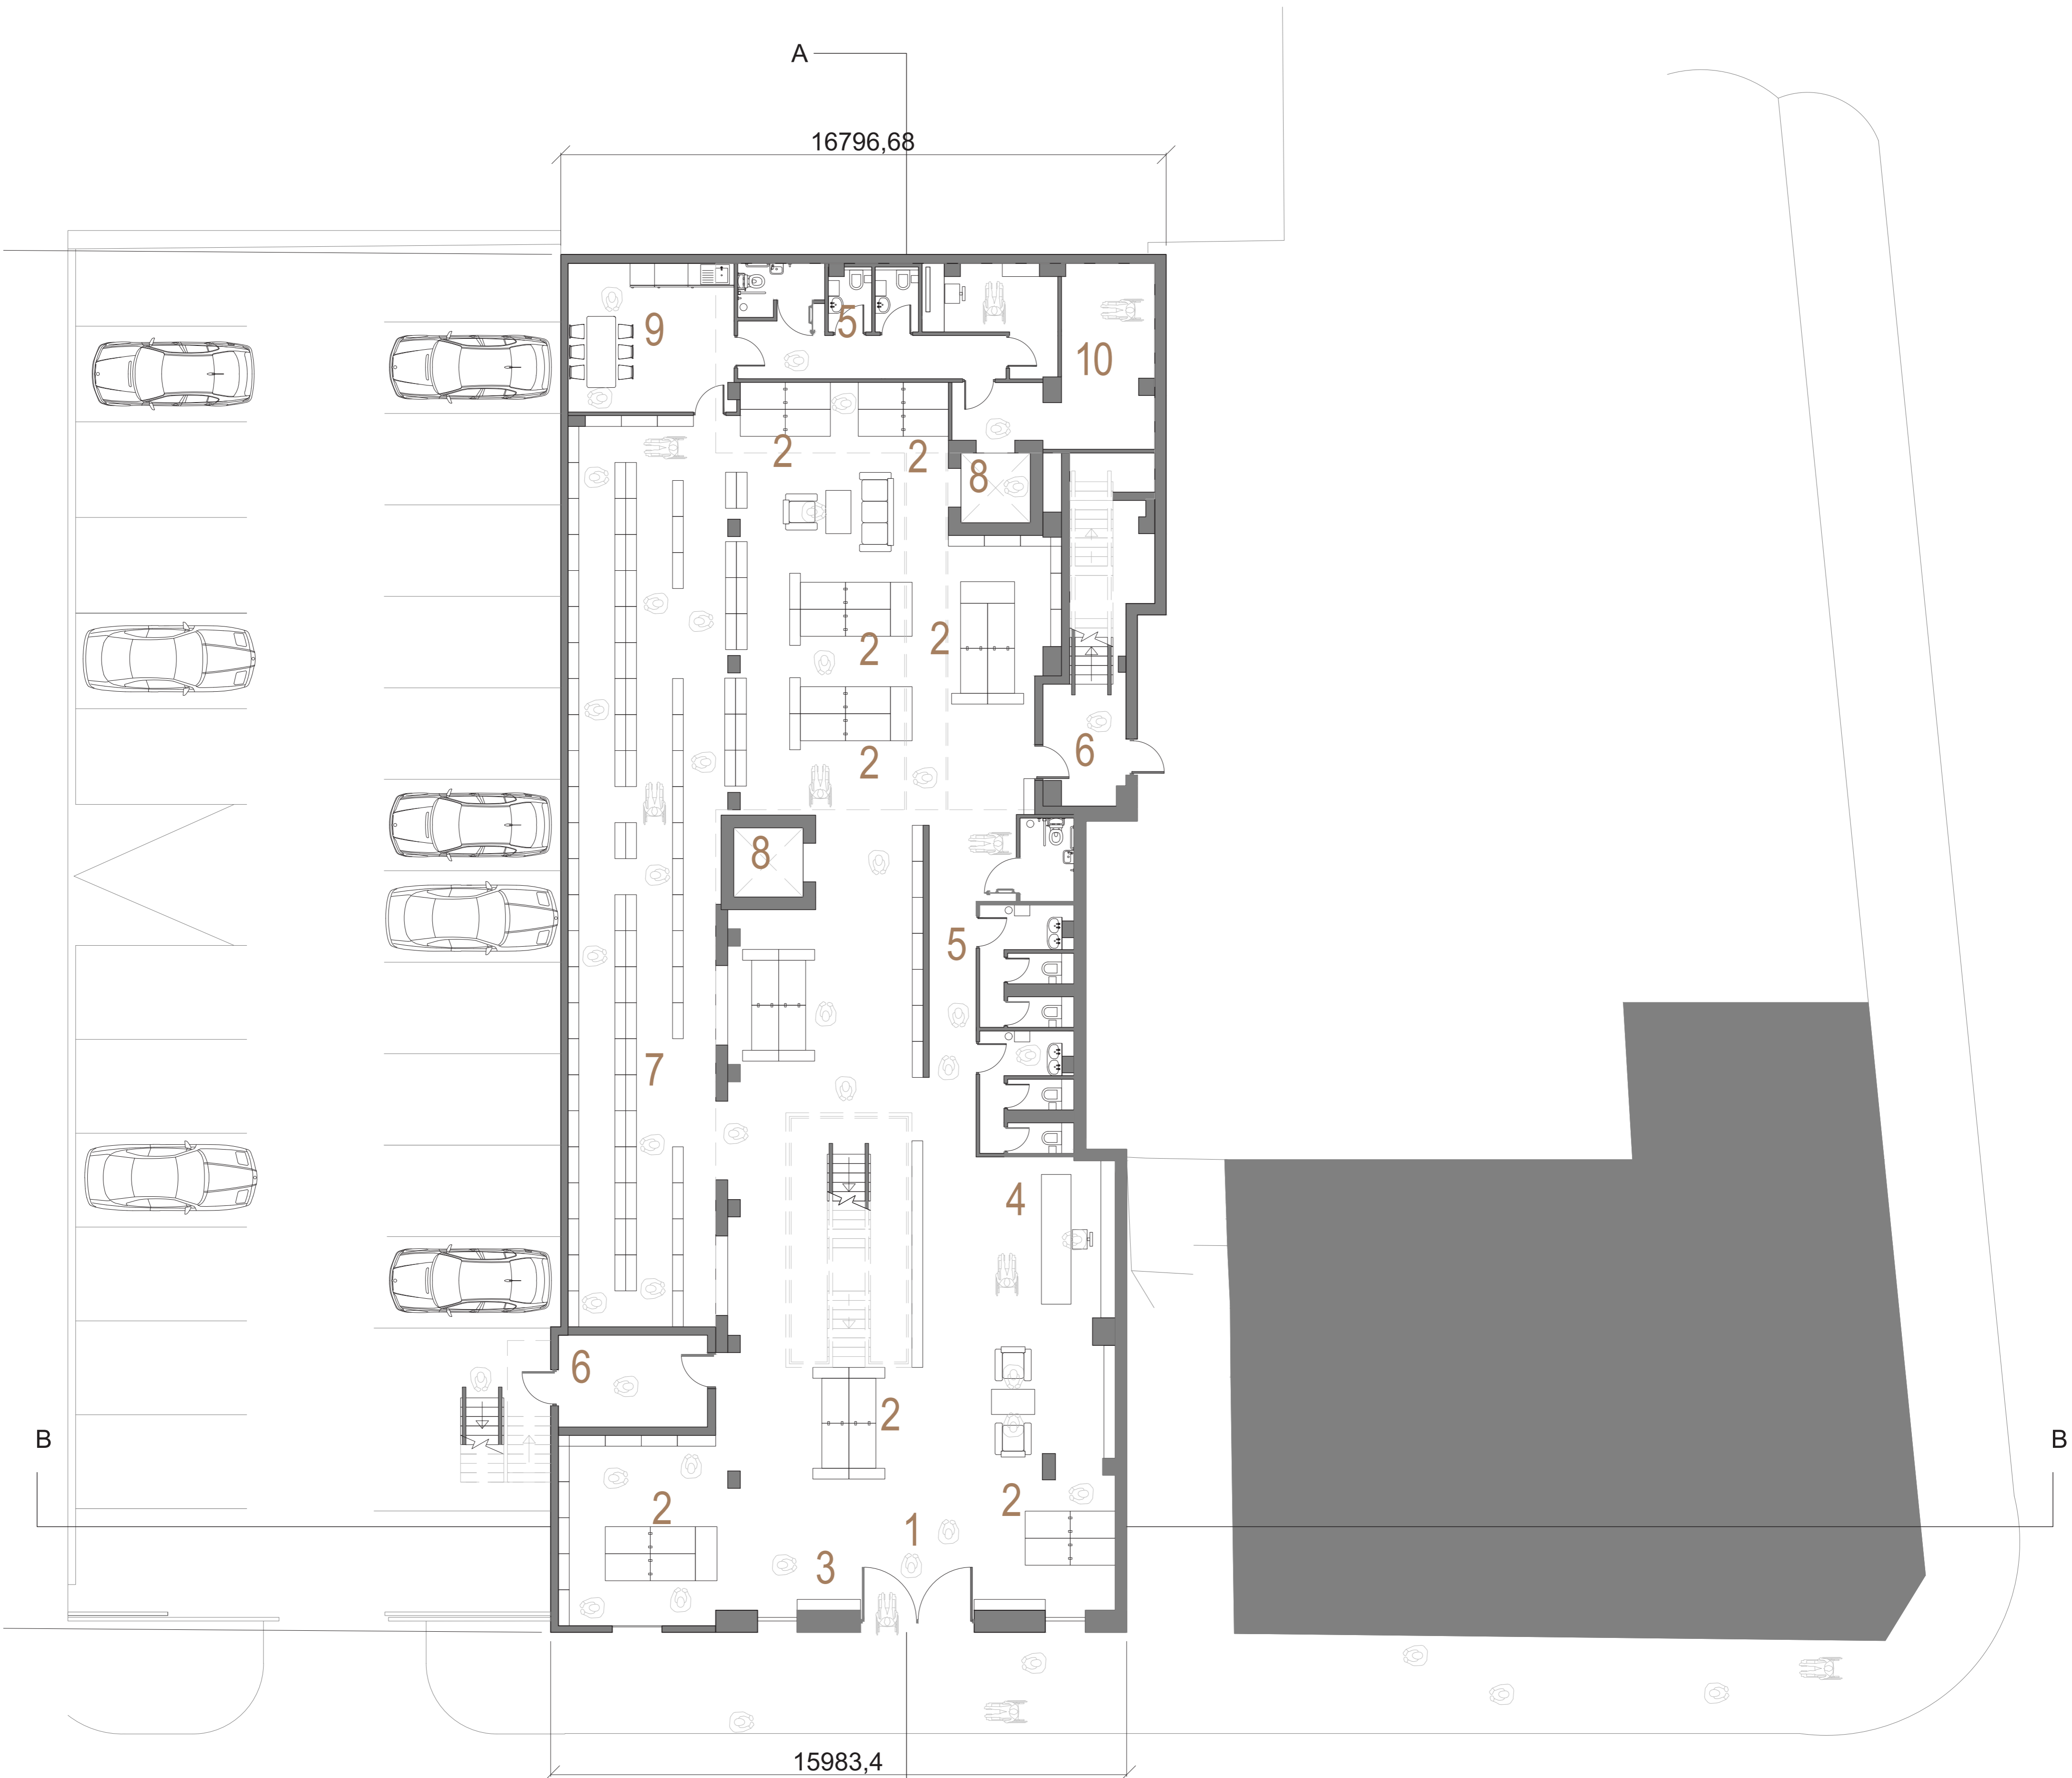

- Key:
- 1- Main entrance
 - 2- Reading space
 - 3- Periodicals
 - 4- Reception
 - 5- W.C
 - 6- Fire escape
 - 7- Books
 - 8- Lift
 - 9- Admin offices, Staff room
 - 10- Storage
 - 11- Practise room
 - 12- Cleaners

Birmingham City University		
Project Name Interior Strategies		
Drawing Title Ground Floor Plan With Context		
Site Address 312-314 Bradford St, Birmingham B5 6ET	Project No. 8	
Date 8 Dec 2022	Scale 1:100	Drawing No. 1





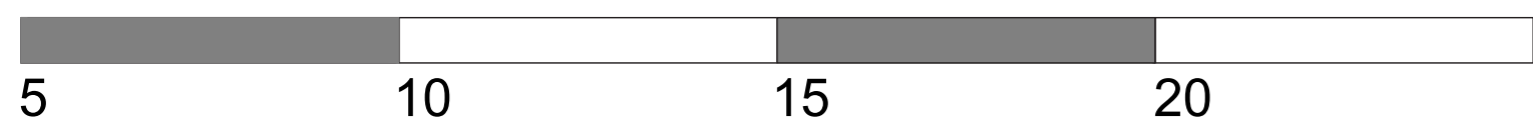



- Key:
- 1- Main entrance
 - 2- Reading space
 - 3- Periodicals
 - 4- Reception
 - 5- W.C
 - 6- Fire escape
 - 7- Books
 - 8- Lift
 - 9- Admin offices, Staff room
 - 10- Storage
 - 11- Practise room
 - 12- Cleaners

Birmingham City University		
Project Name		
Interior Strategies		
Drawing Title		
Mezzanine Floor Plan With Context		
Site Address		Project No.
312-314 Bradford St, Birmingham B5 6ET		8
Date	Scale	Drawing No.
8 Dec 2022	1:100	2




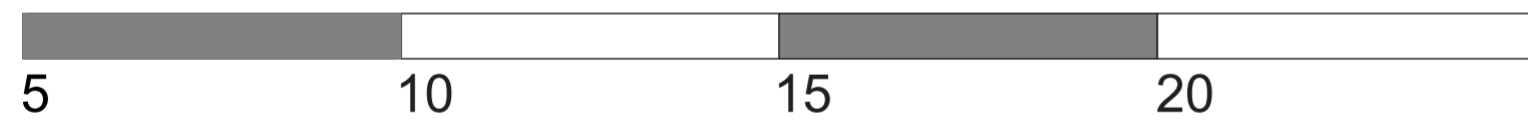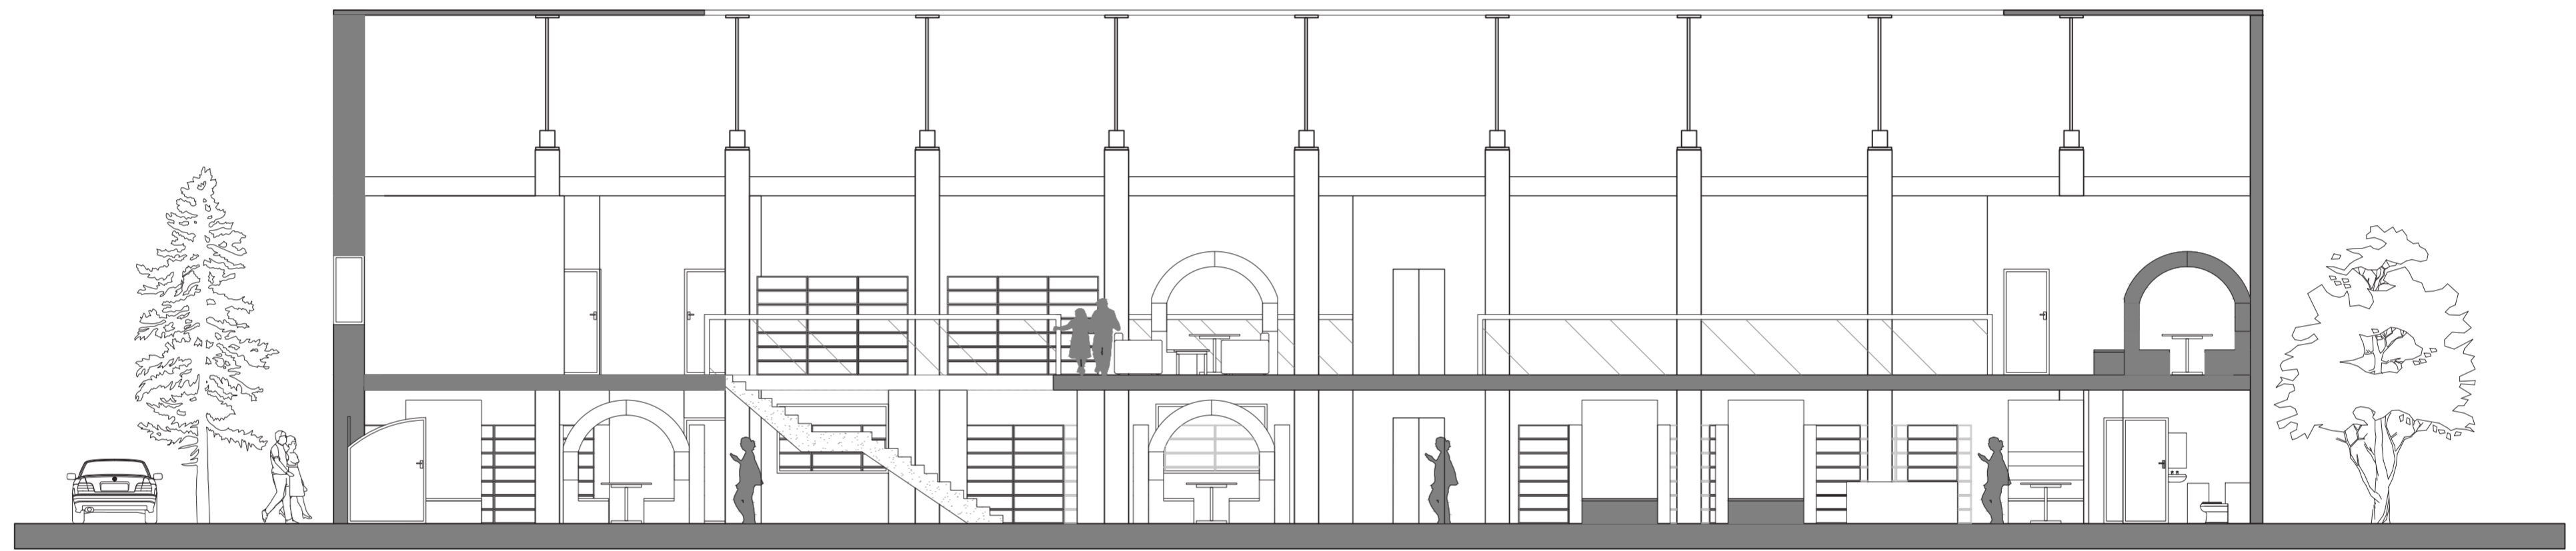

Birmingham City University		
Project Name		
Interior Strategies		
Drawing Title		
Section A		
Site Address	Project No.	
312-314 Bradford St, Birmingham B5 6ET	8	
Date	Scale	Drawing No.
8 Dec 2022	1:100	3

 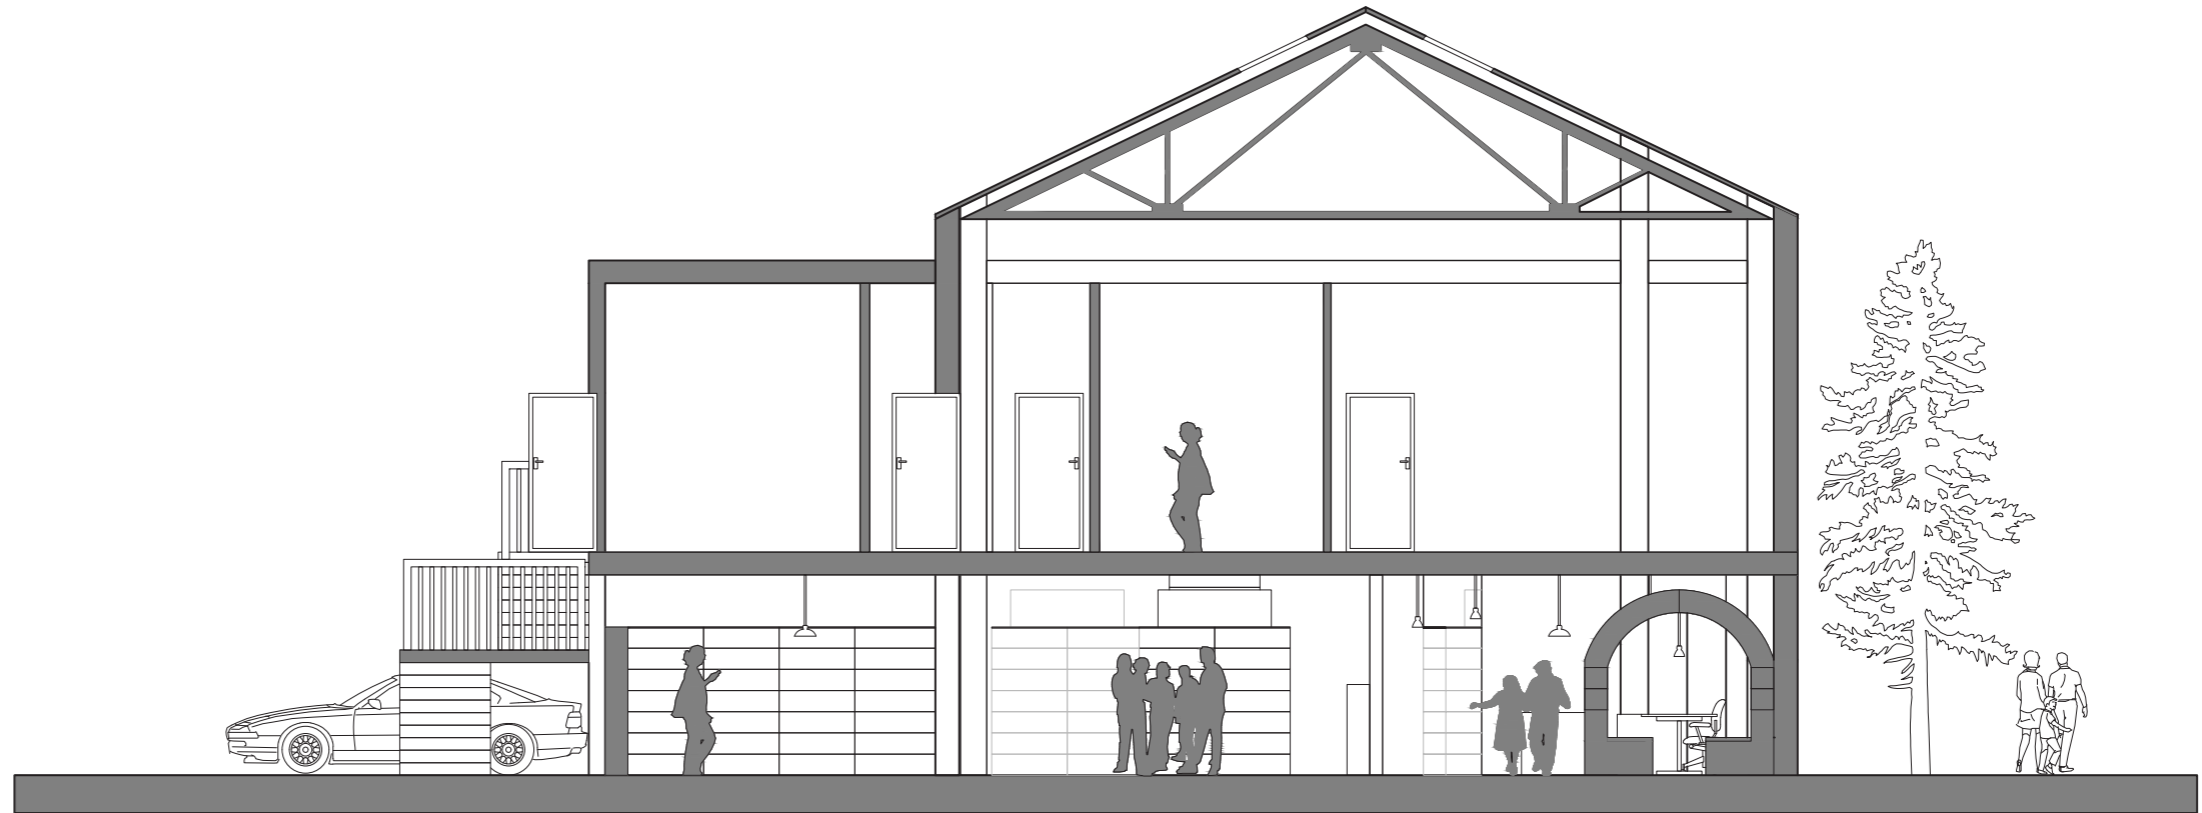

Birmingham City University		
Project Name		
Interior Strategies		
Drawing Title		
Section B		
Site Address		Project No.
312-314 Bradford St, Birmingham B5 6ET		8
Date	Scale	Drawing No.
8 Dec 2022	1:100	4

 

**Birmingham City
University**

Project Name

Interior Strategies

Drawing Title

Facade Elevation

Site Address

**312-314 Bradford St,
Birmingham B5 6ET**

Project No.

8

Date

 

8 Dec 2022

Scale




1:100

Drawing No.

5

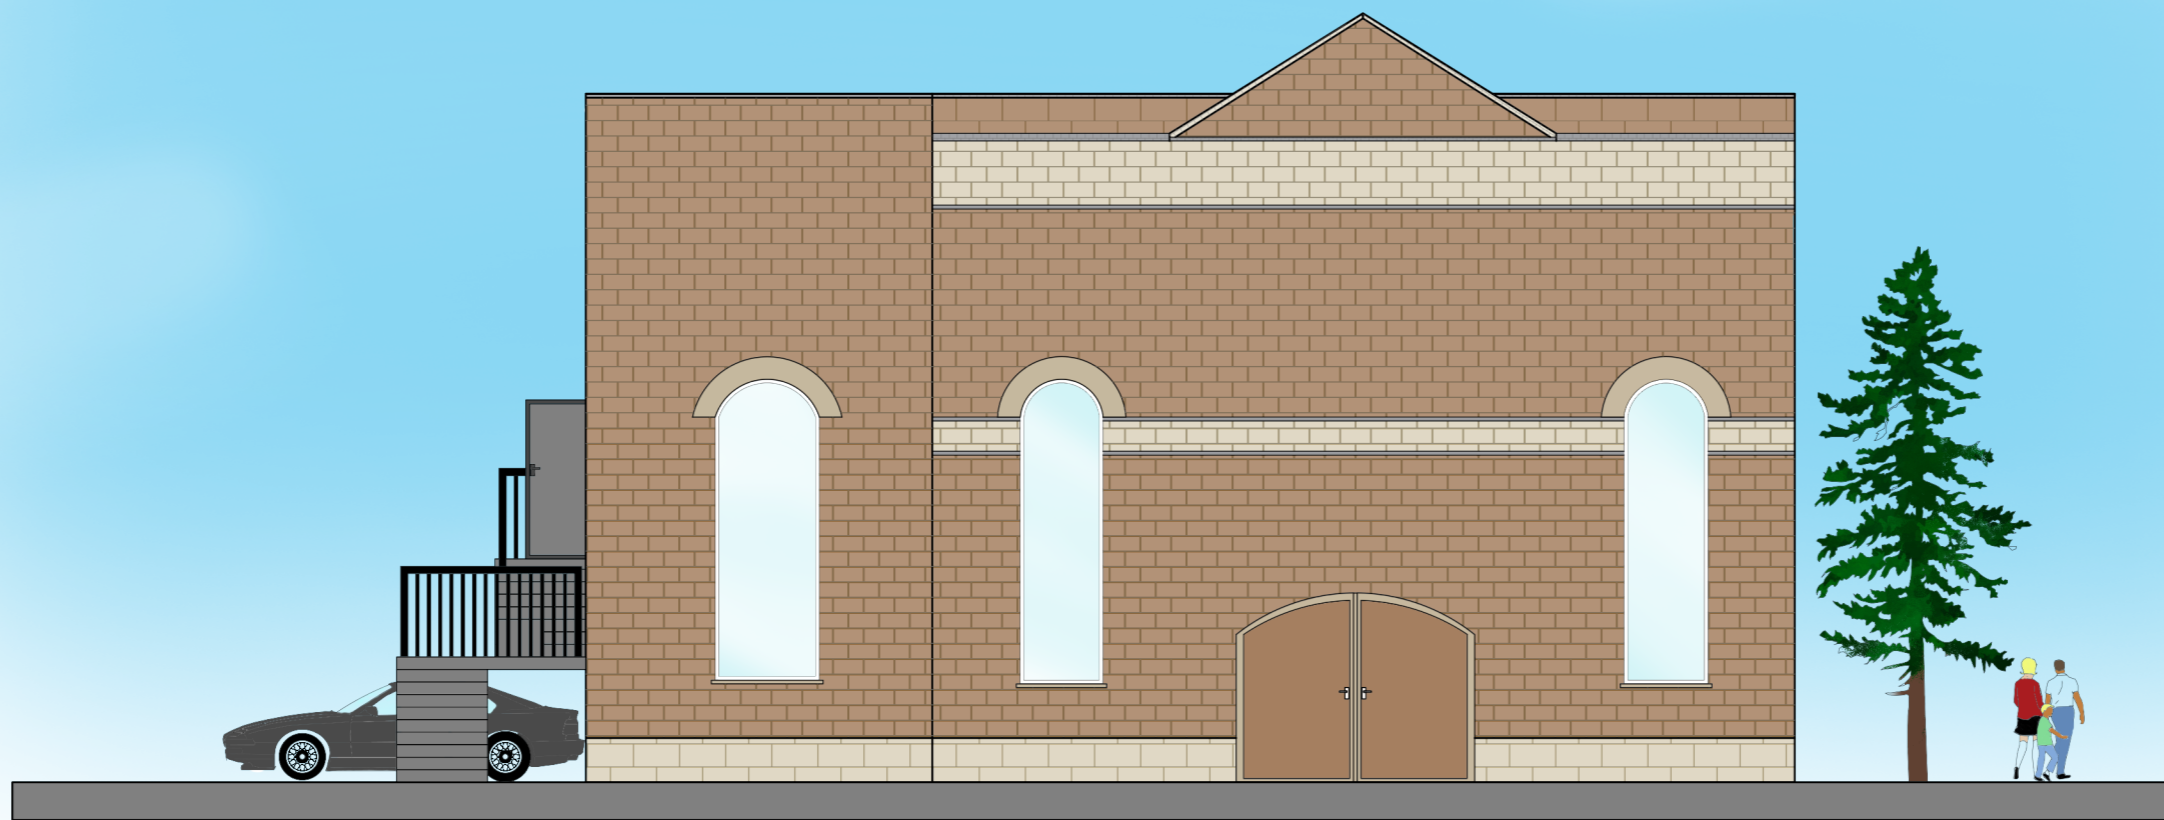

Birmingham City University		
Project Name		
Interior Strategies		
Drawing Title		
Facade Elevation Render		
Site Address	Project No.	
312-314 Bradford St, Birmingham B5 6ET	8	
Date	Scale	Drawing No.
8 Dec 2022	1:100	6

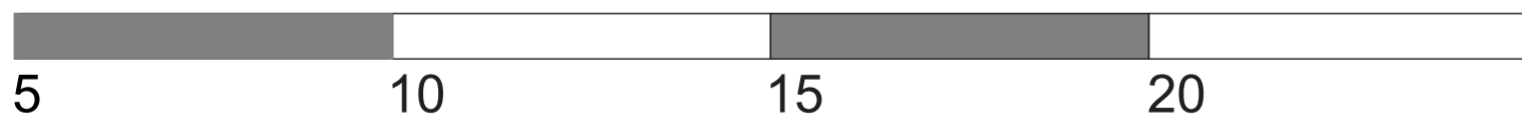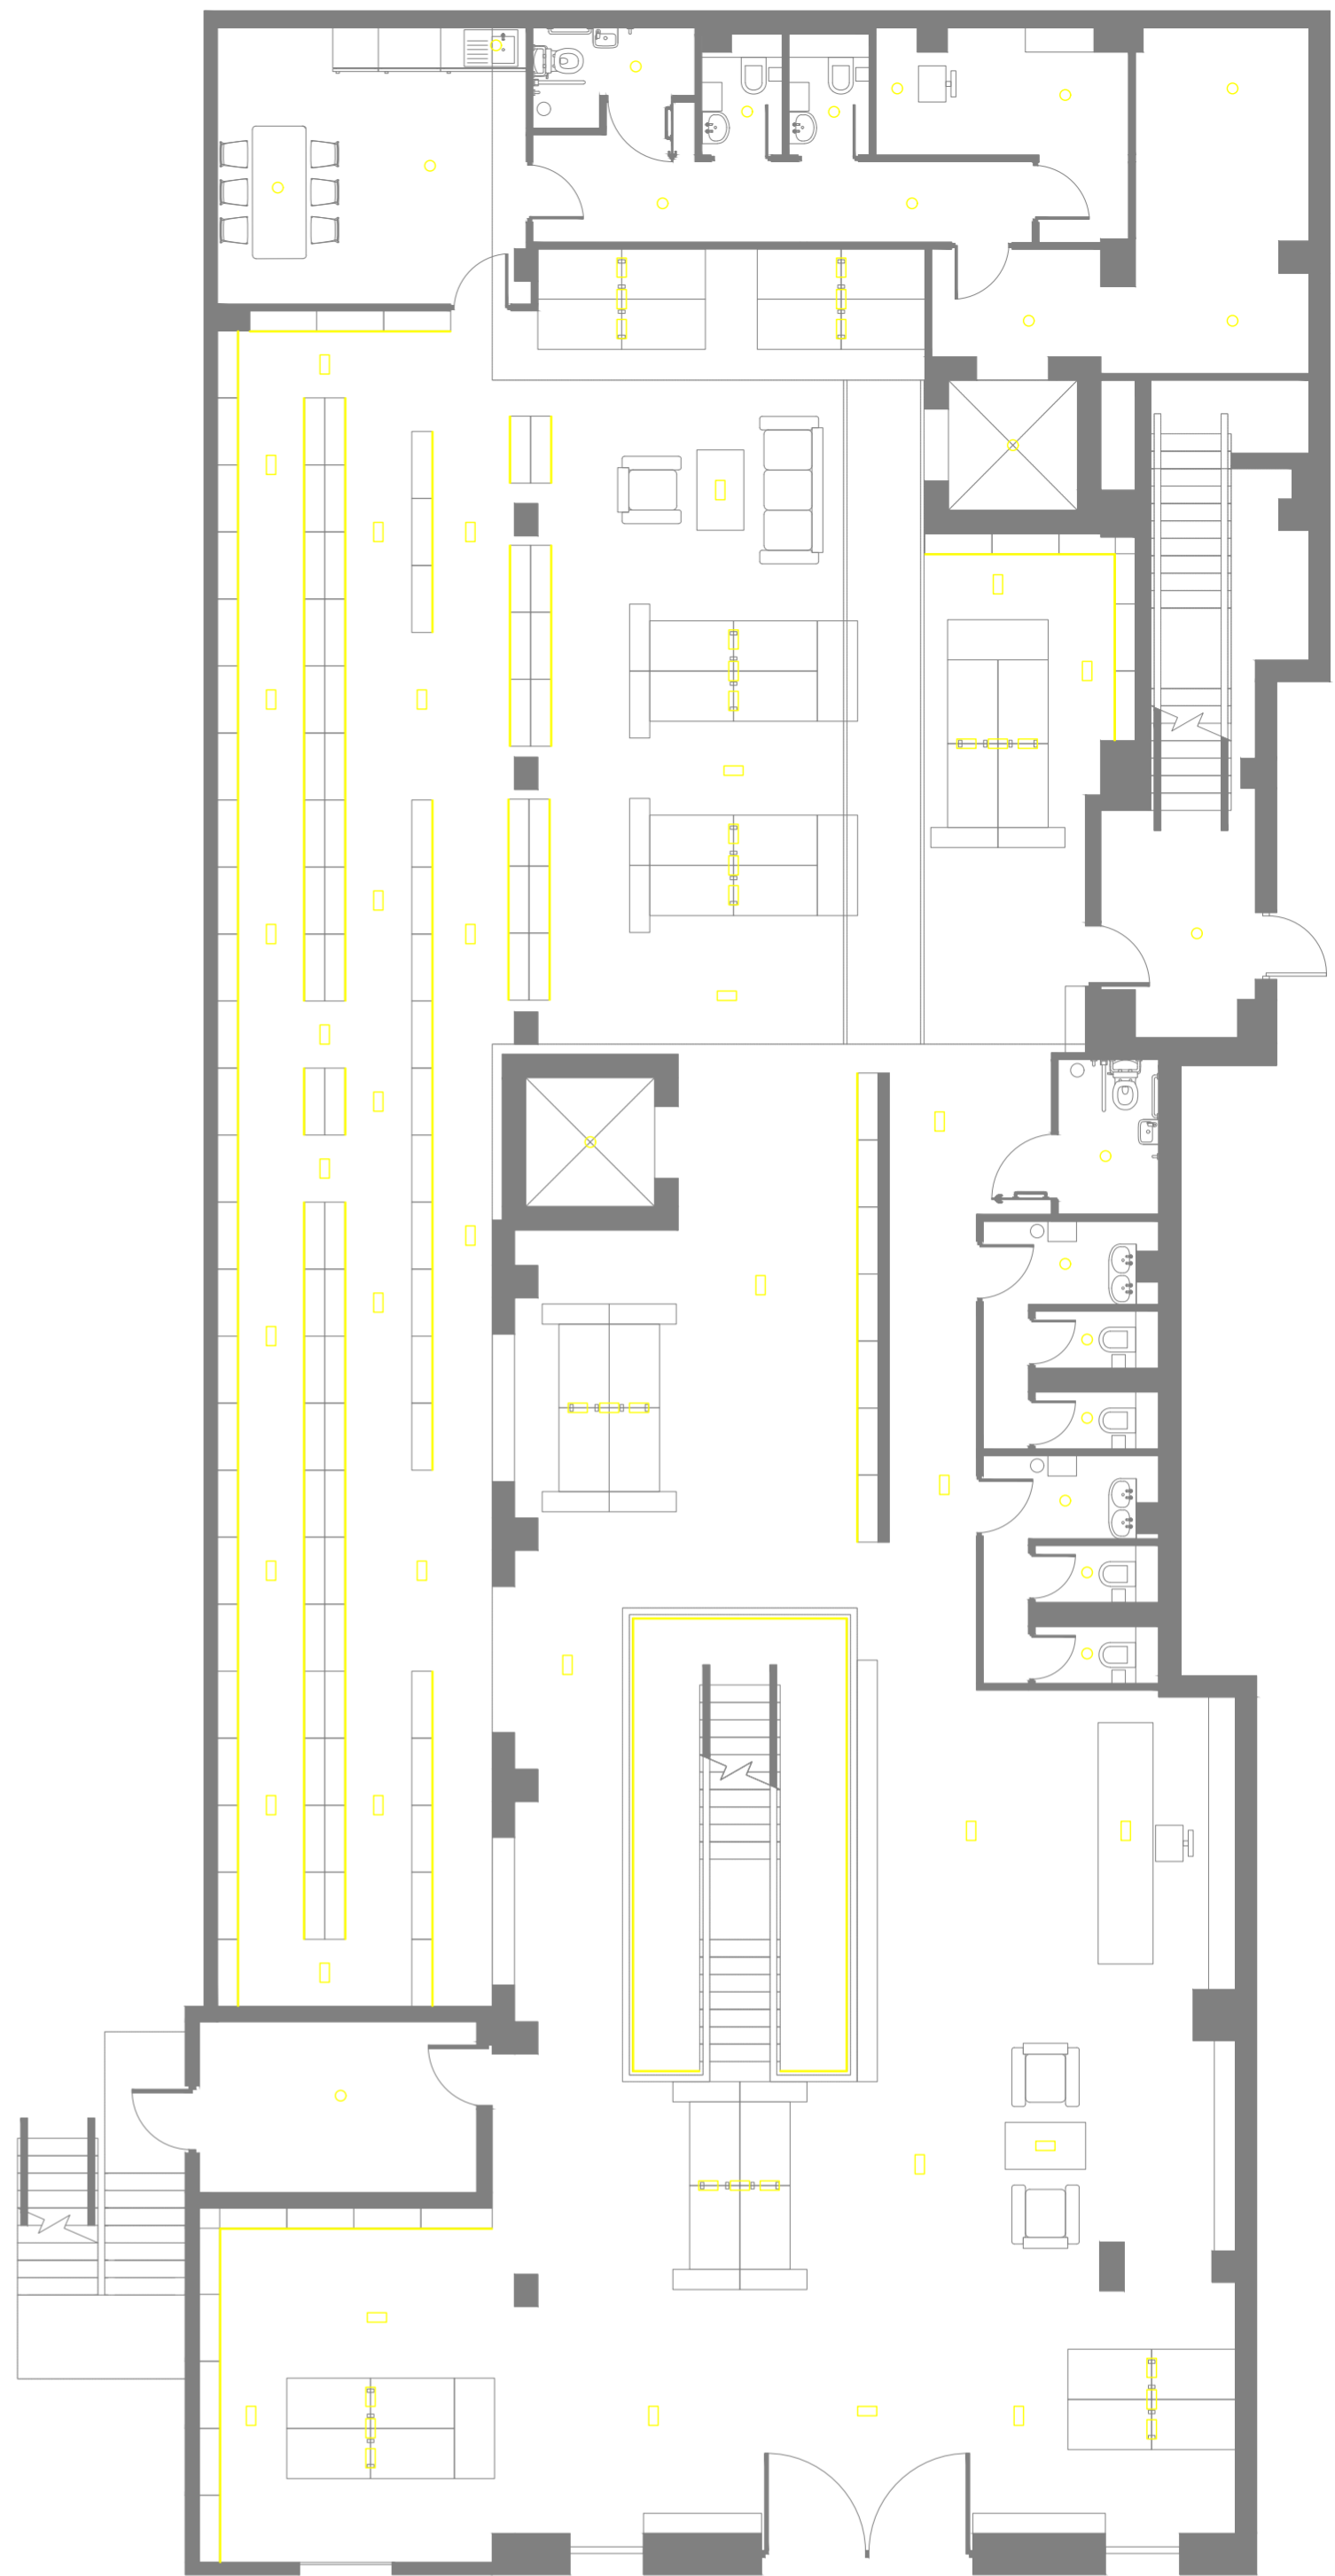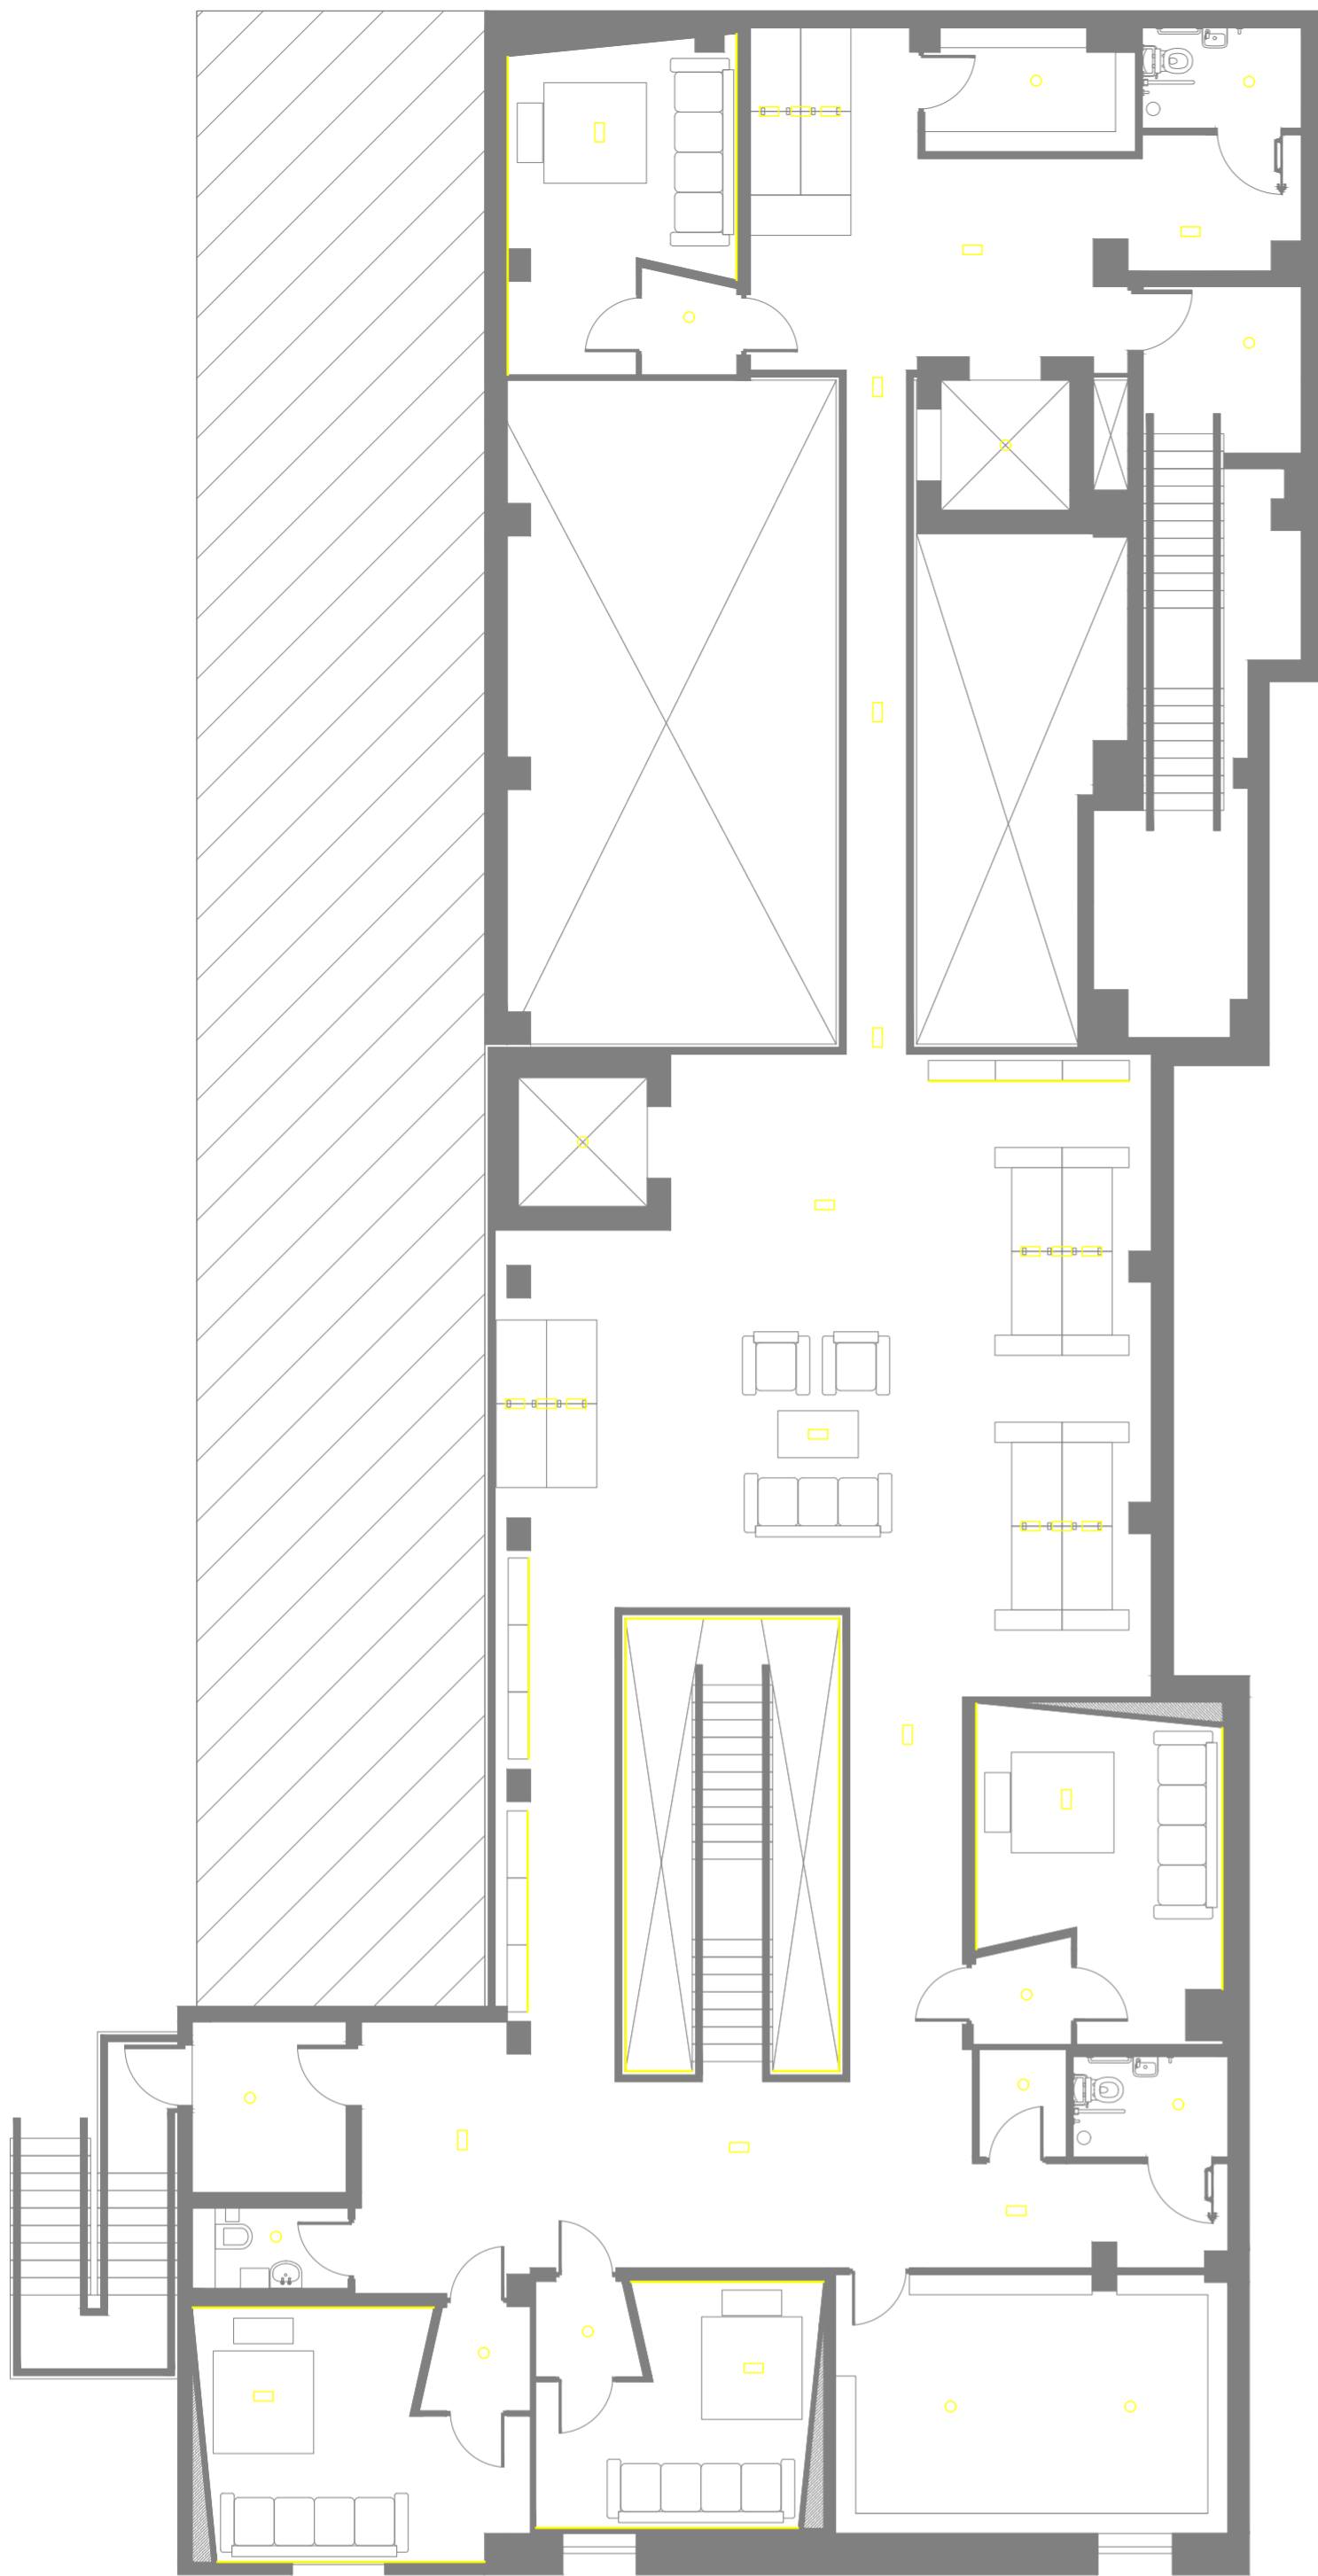

FIXTURE SCHEDULE		
Symbol	Type	Description
○	F1	Recessed down light
□	F2	Kaiser-idell Pendant Lamp
—	F2	LED strip light

Birmingham City University

Project Name

Interior Strategies

Drawing Title

Lighting Plan

Site Address

**312-314 Bradford St,
Birmingham B5 6ET**

Project No.

8

Date

8 Dec 2022

Scale

1:100

Drawing No.


7



Key:



Next Day Flooring
 Polyflor Polysafe Standard Pur Commercial
 Vinyl Flooring
 Black Walnut 4150

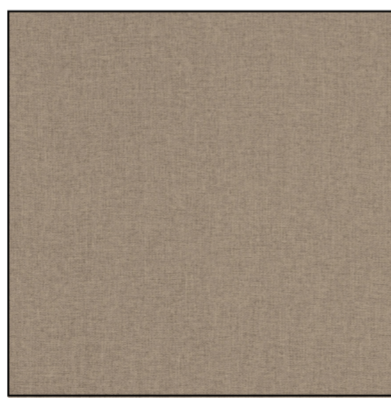

Forbo Flooring Systems
 Sarlon
 19 db Material
 303T4319 Sand Nairobi



Forbo Flooring Systems
 Safestep R11
 174862 Silver Grey



Forbo Flooring Systems
 Eternal
 De Luxe Decibel
 3010/30102 Warm Honey Oak

Birmingham City University

Project Name

Interior Strategies

Drawing Title

Ground Floor and Mezzanine Rendered Finishes Layout

Site Address

**312-314 Bradford St,
 Birmingham B5 6ET**

Project No.

8

Date

8 Dec 2022

Scale


1:100

Drawing No.

8

Key:

Escape routes -

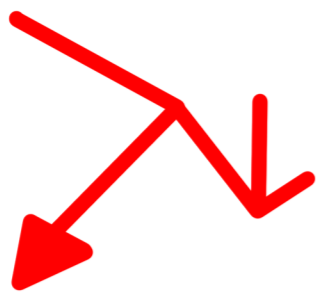

Fire Walls -



User Circulation -





Staff Circulation -




Refuge Area -



Birmingham City University		
Project Name Interior Strategies		
Drawing Title Circulation Strategy		
Site Address 312-314 Bradford St, Birmingham B5 6ET	Project No. 8	
Date 8 Dec 2022	Scale 1:100	Drawing No. 9

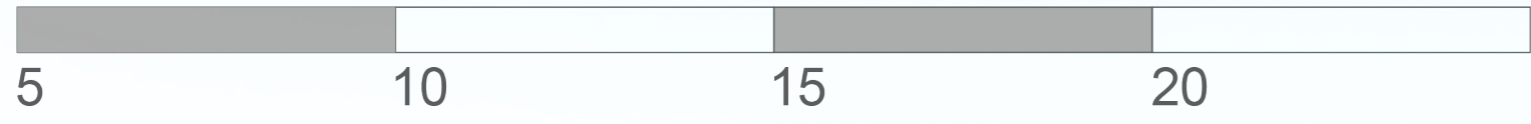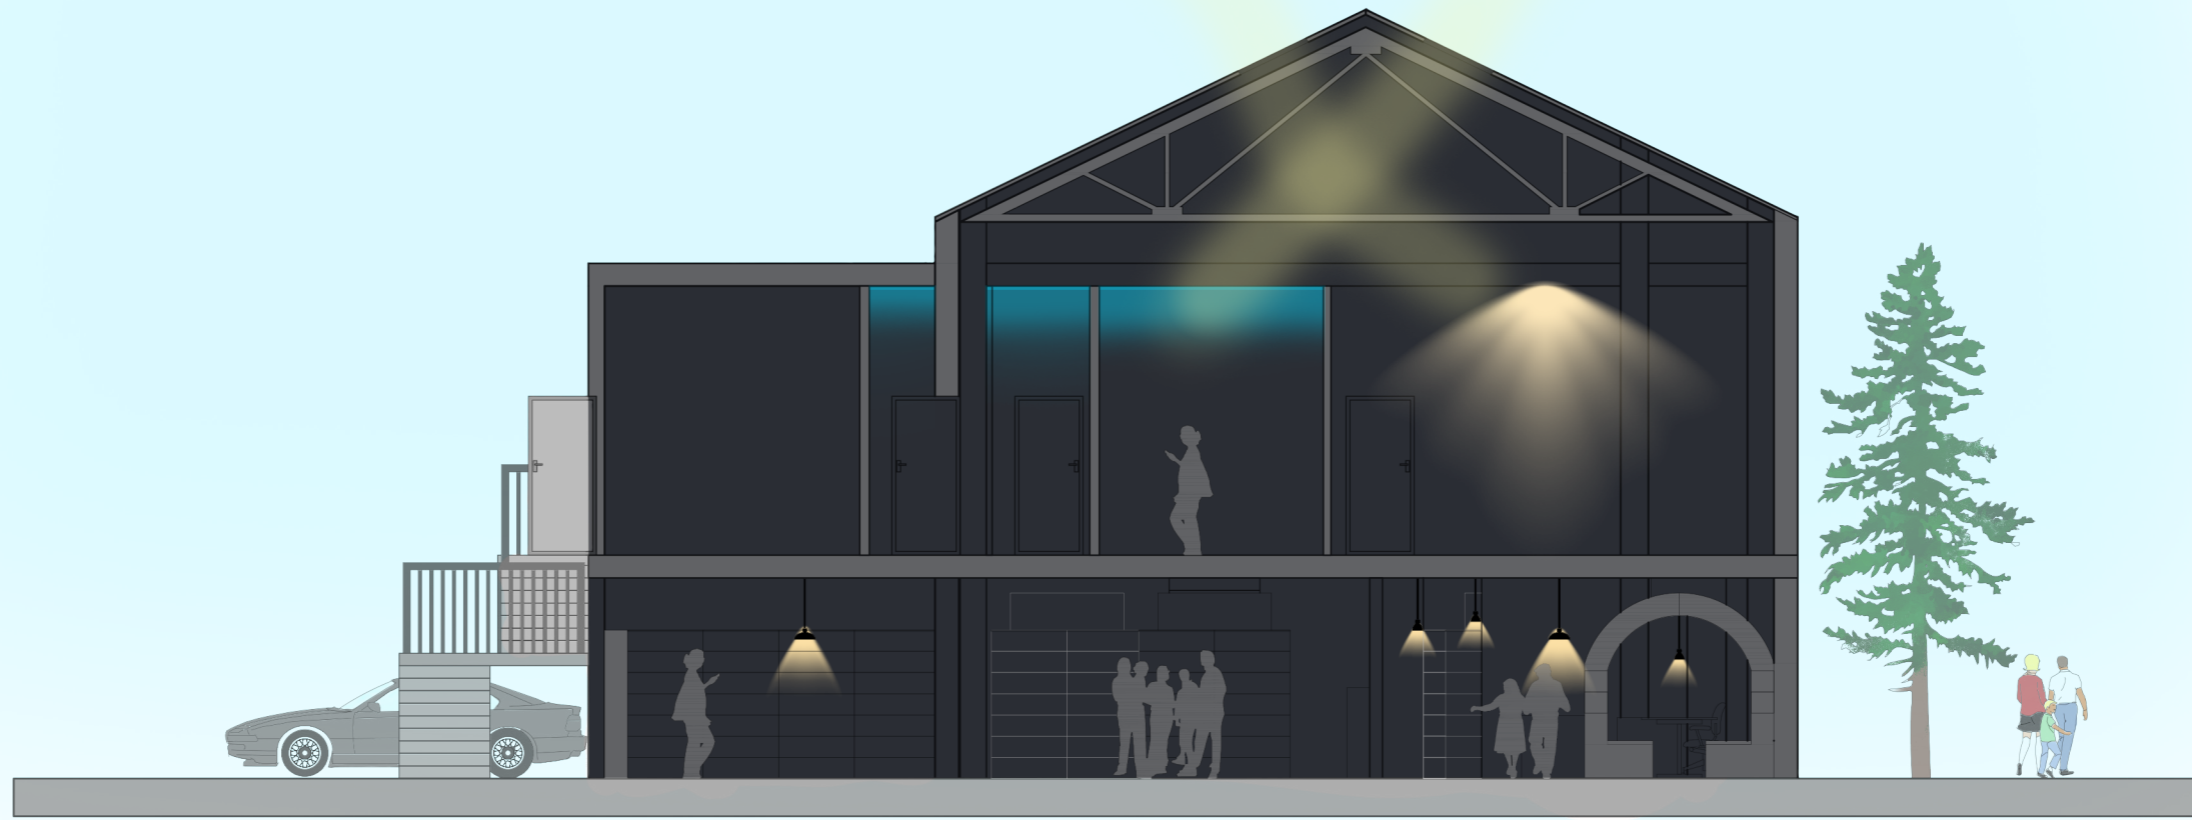

Birmingham City University		
Project Name Interior Strategies		
Drawing Title Section B Lighting Render		
Site Address 312-314 Bradford St, Birmingham B5 6ET	Project No. 8	
Date 8 Dec 2022	Scale 1:100	Drawing No. 10

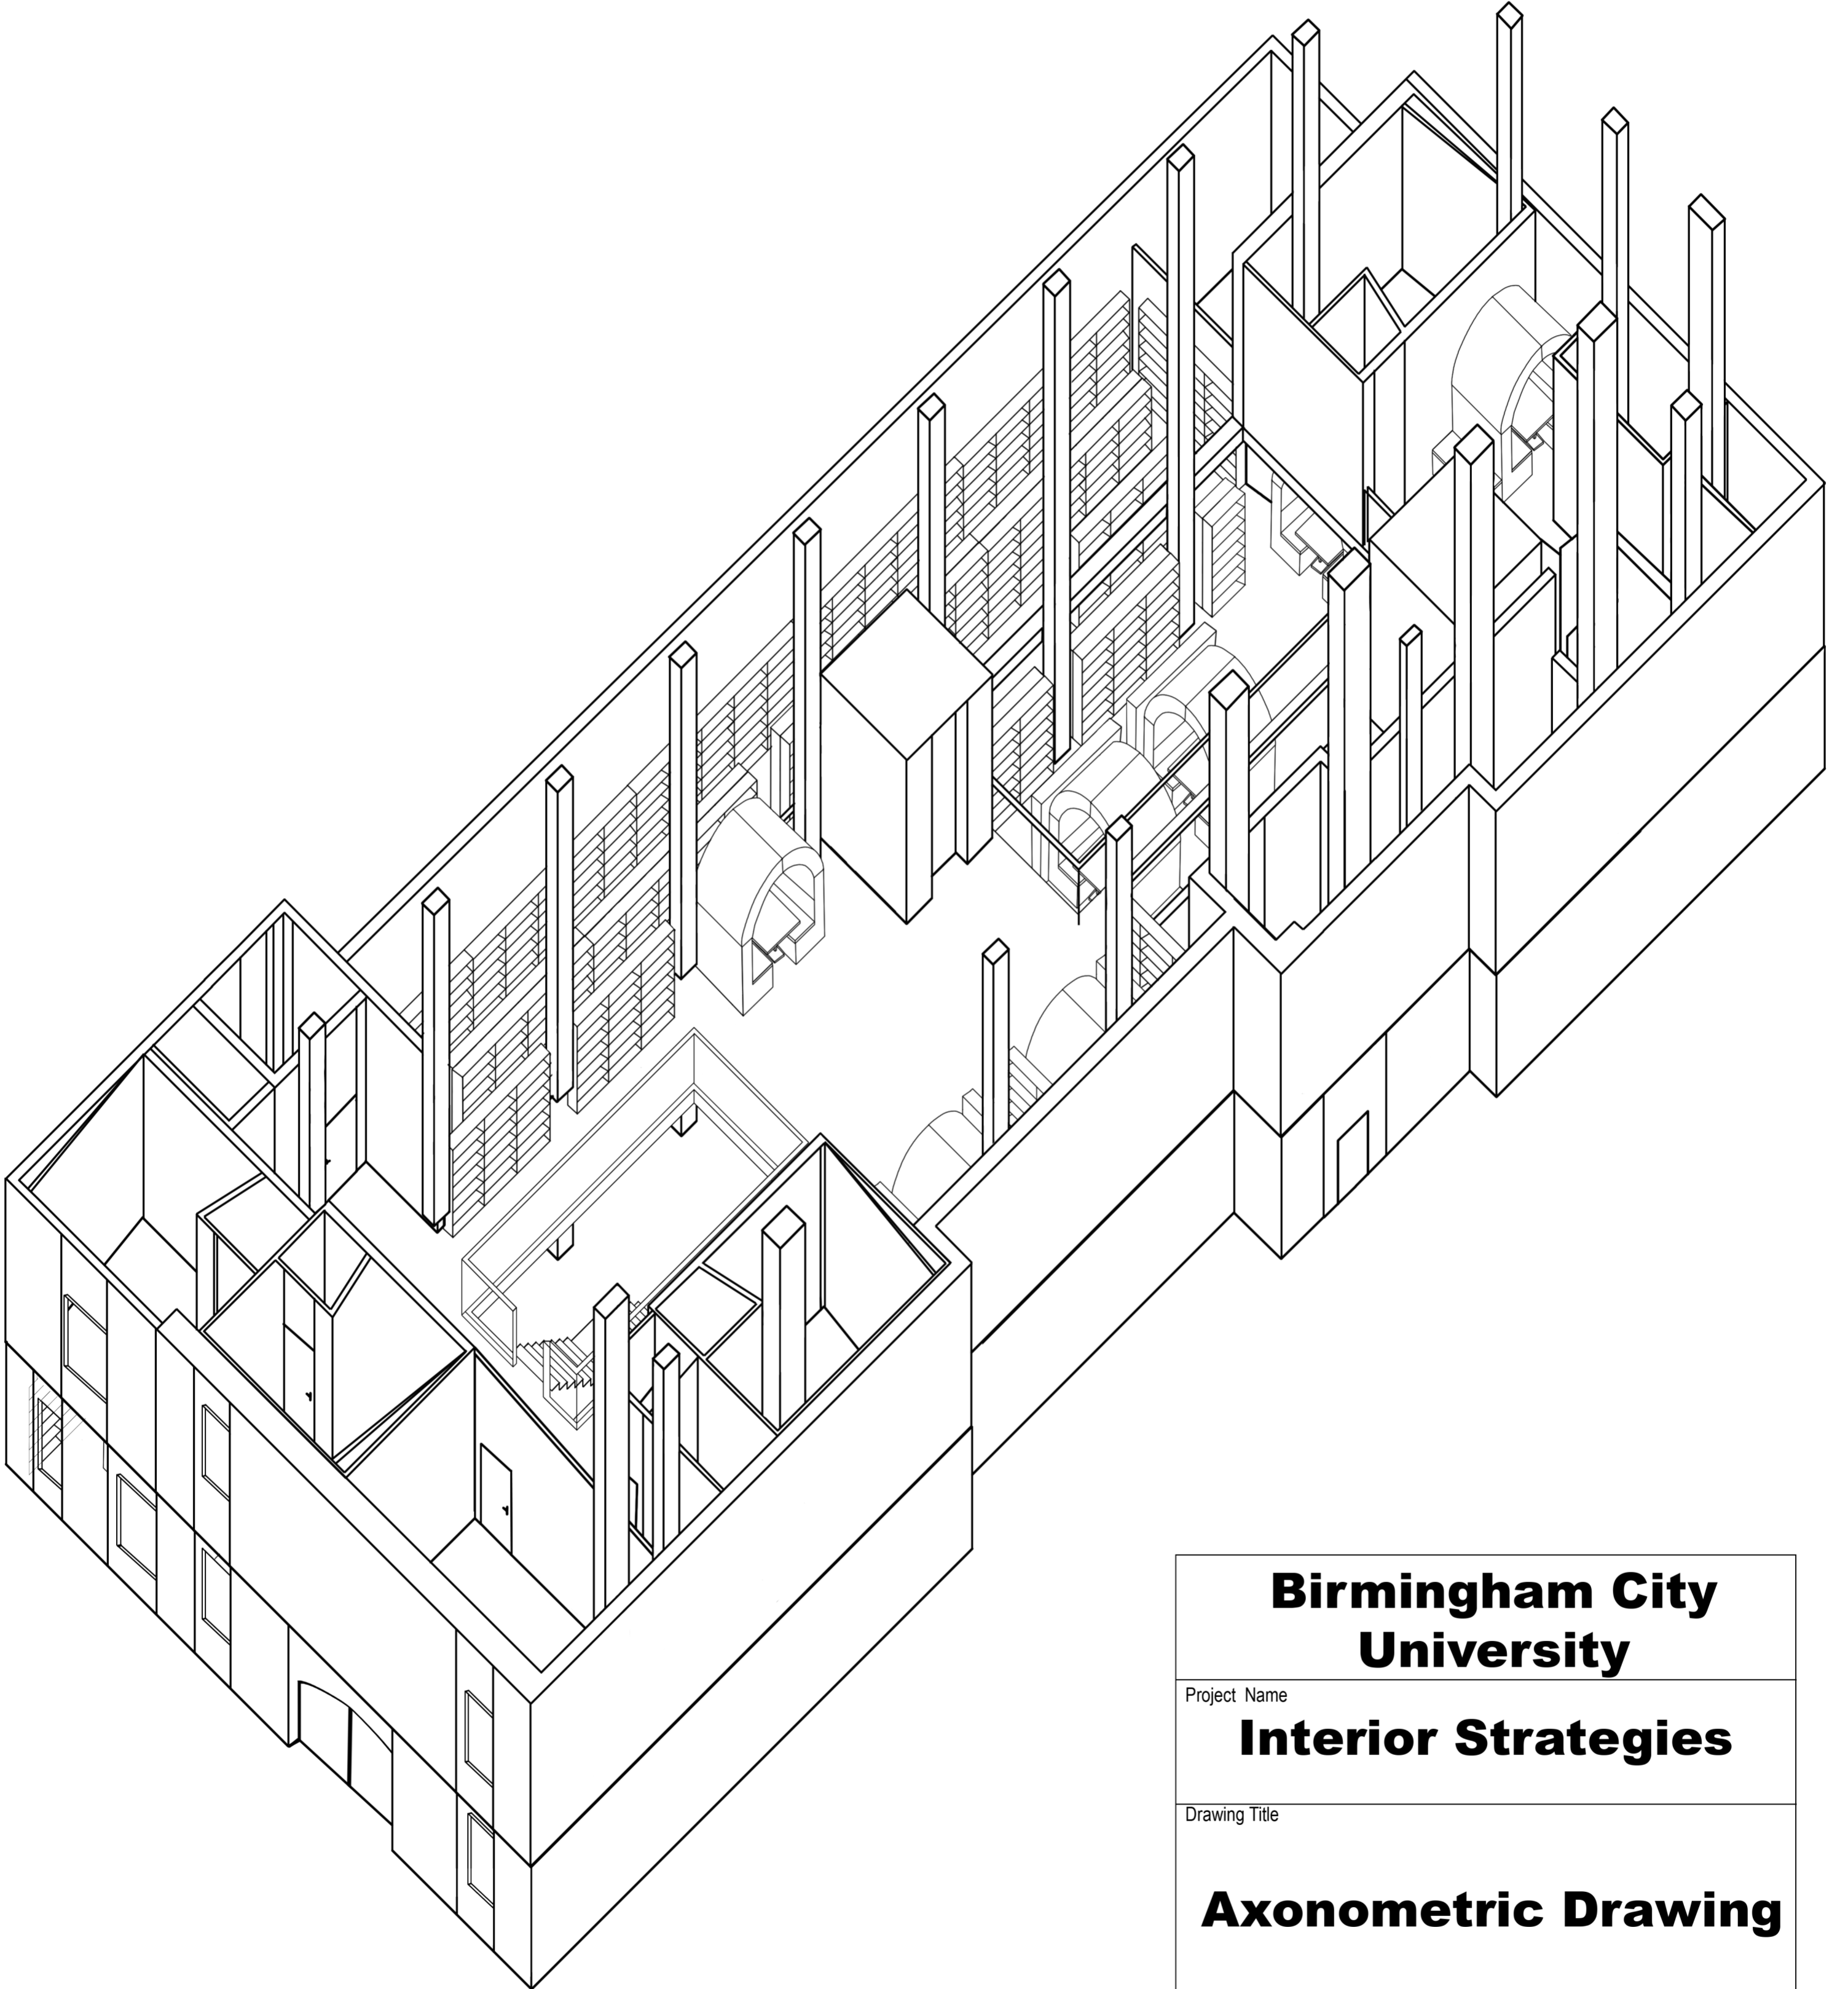

Birmingham City University

Project Name

Interior Strategies

Drawing Title

Axonometric Drawing

Site Address

**312-314 Bradford St,
Birmingham B5 6ET**

Project No.


8

Date


8 Dec 2022

Drawing No.

11

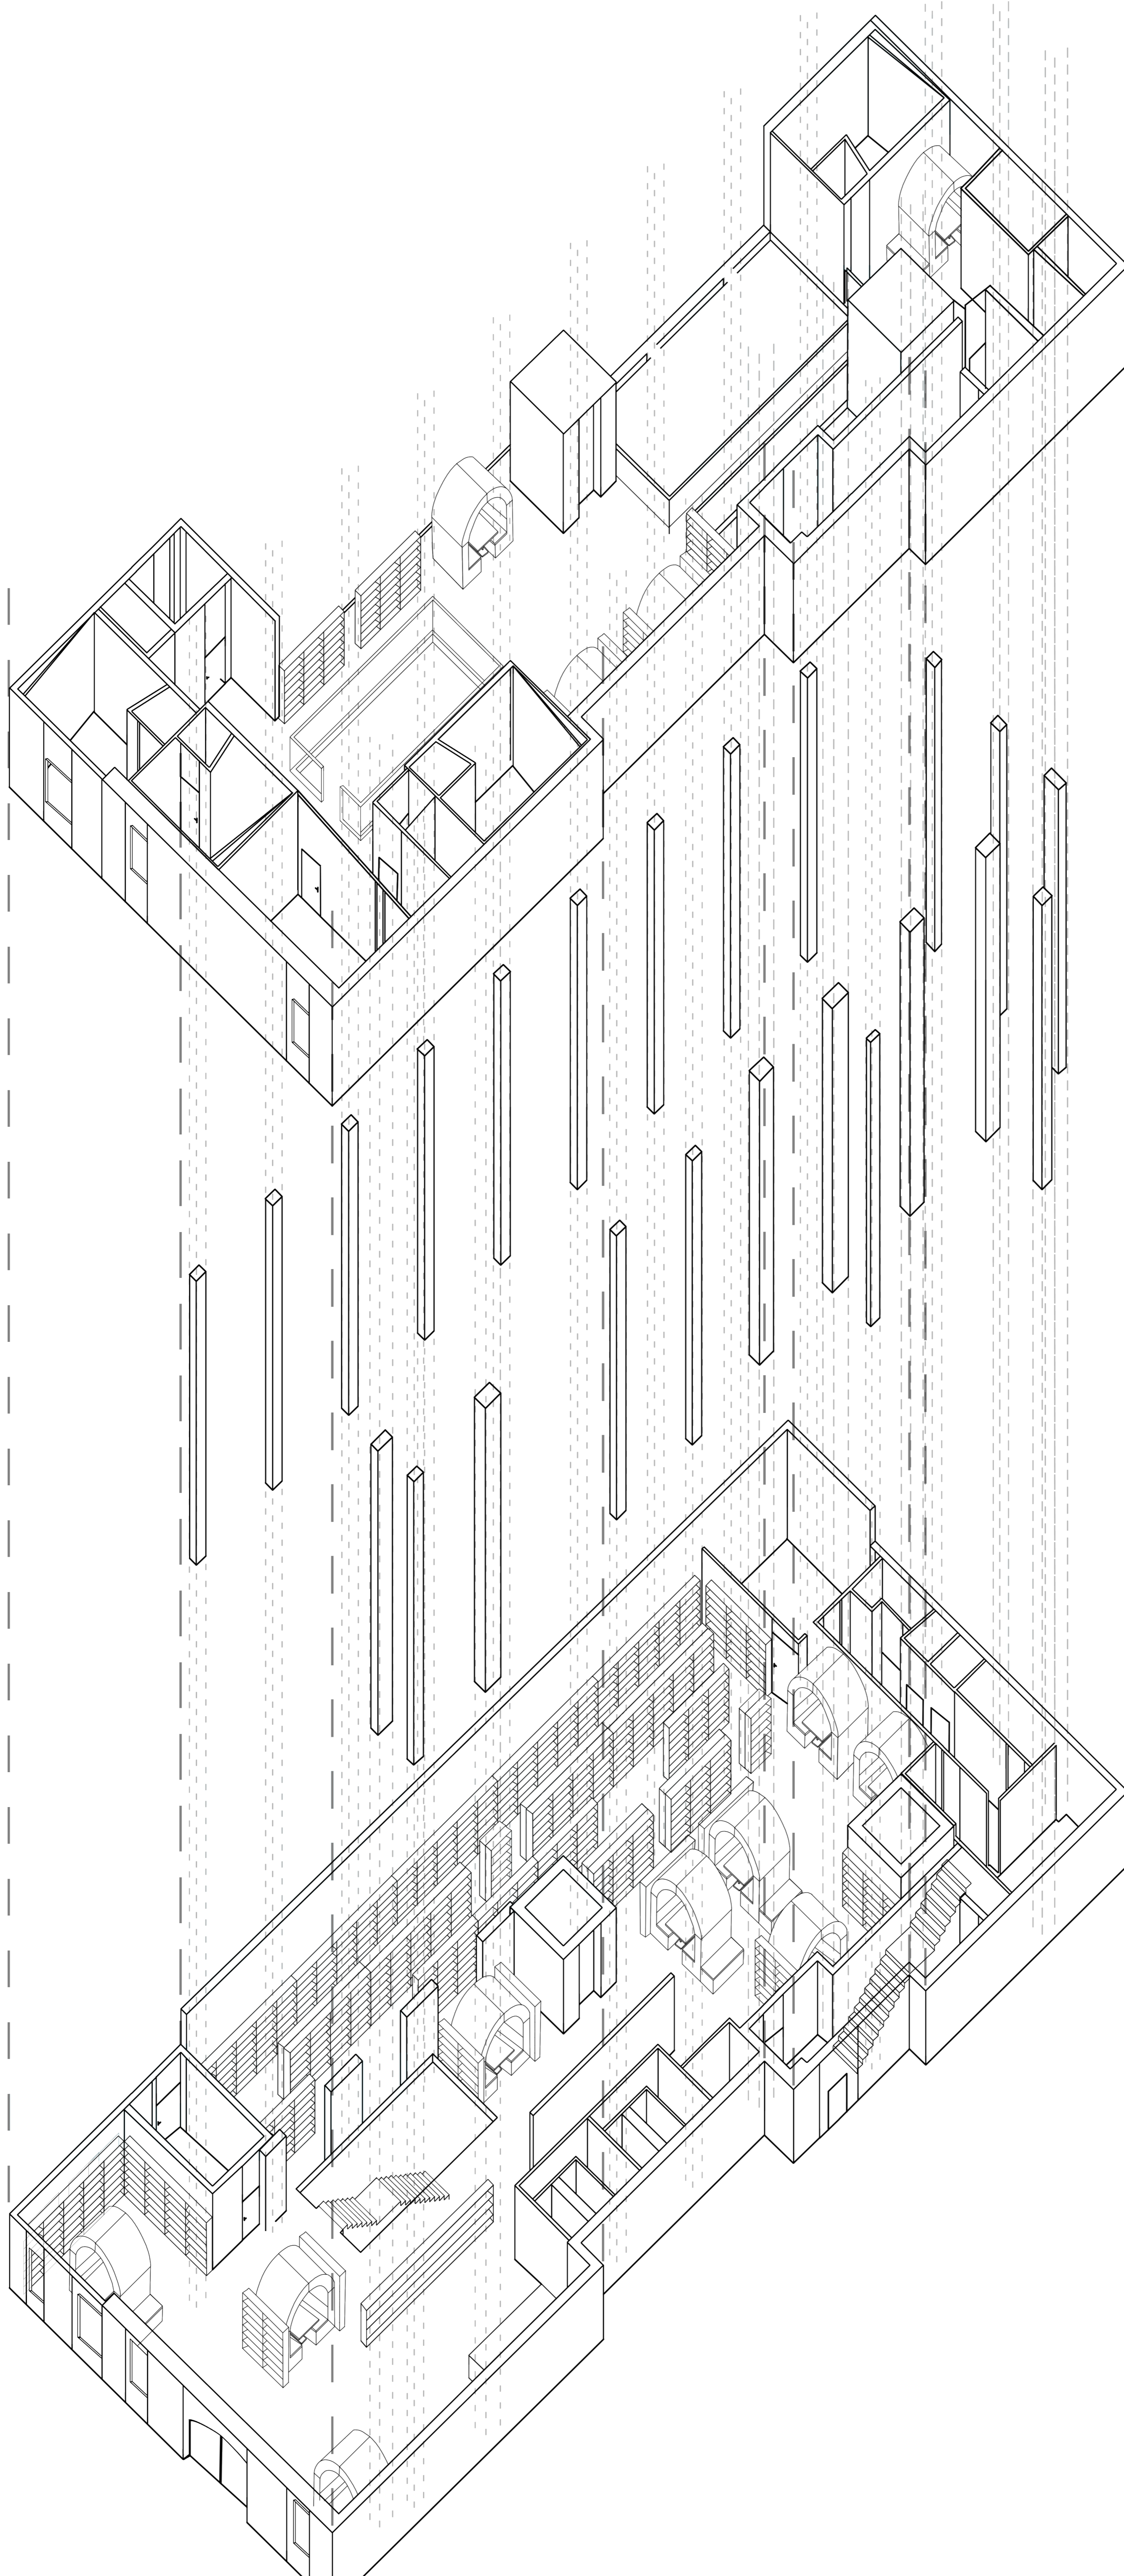

Birmingham City University	
Project Name Interior Strategies	
Drawing Title Exploded Axonometric Drawing	
Site Address 312-314 Bradford St, Birmingham B5 6ET	Project No. 8
Date 8 Dec 2022	Drawing No. 12

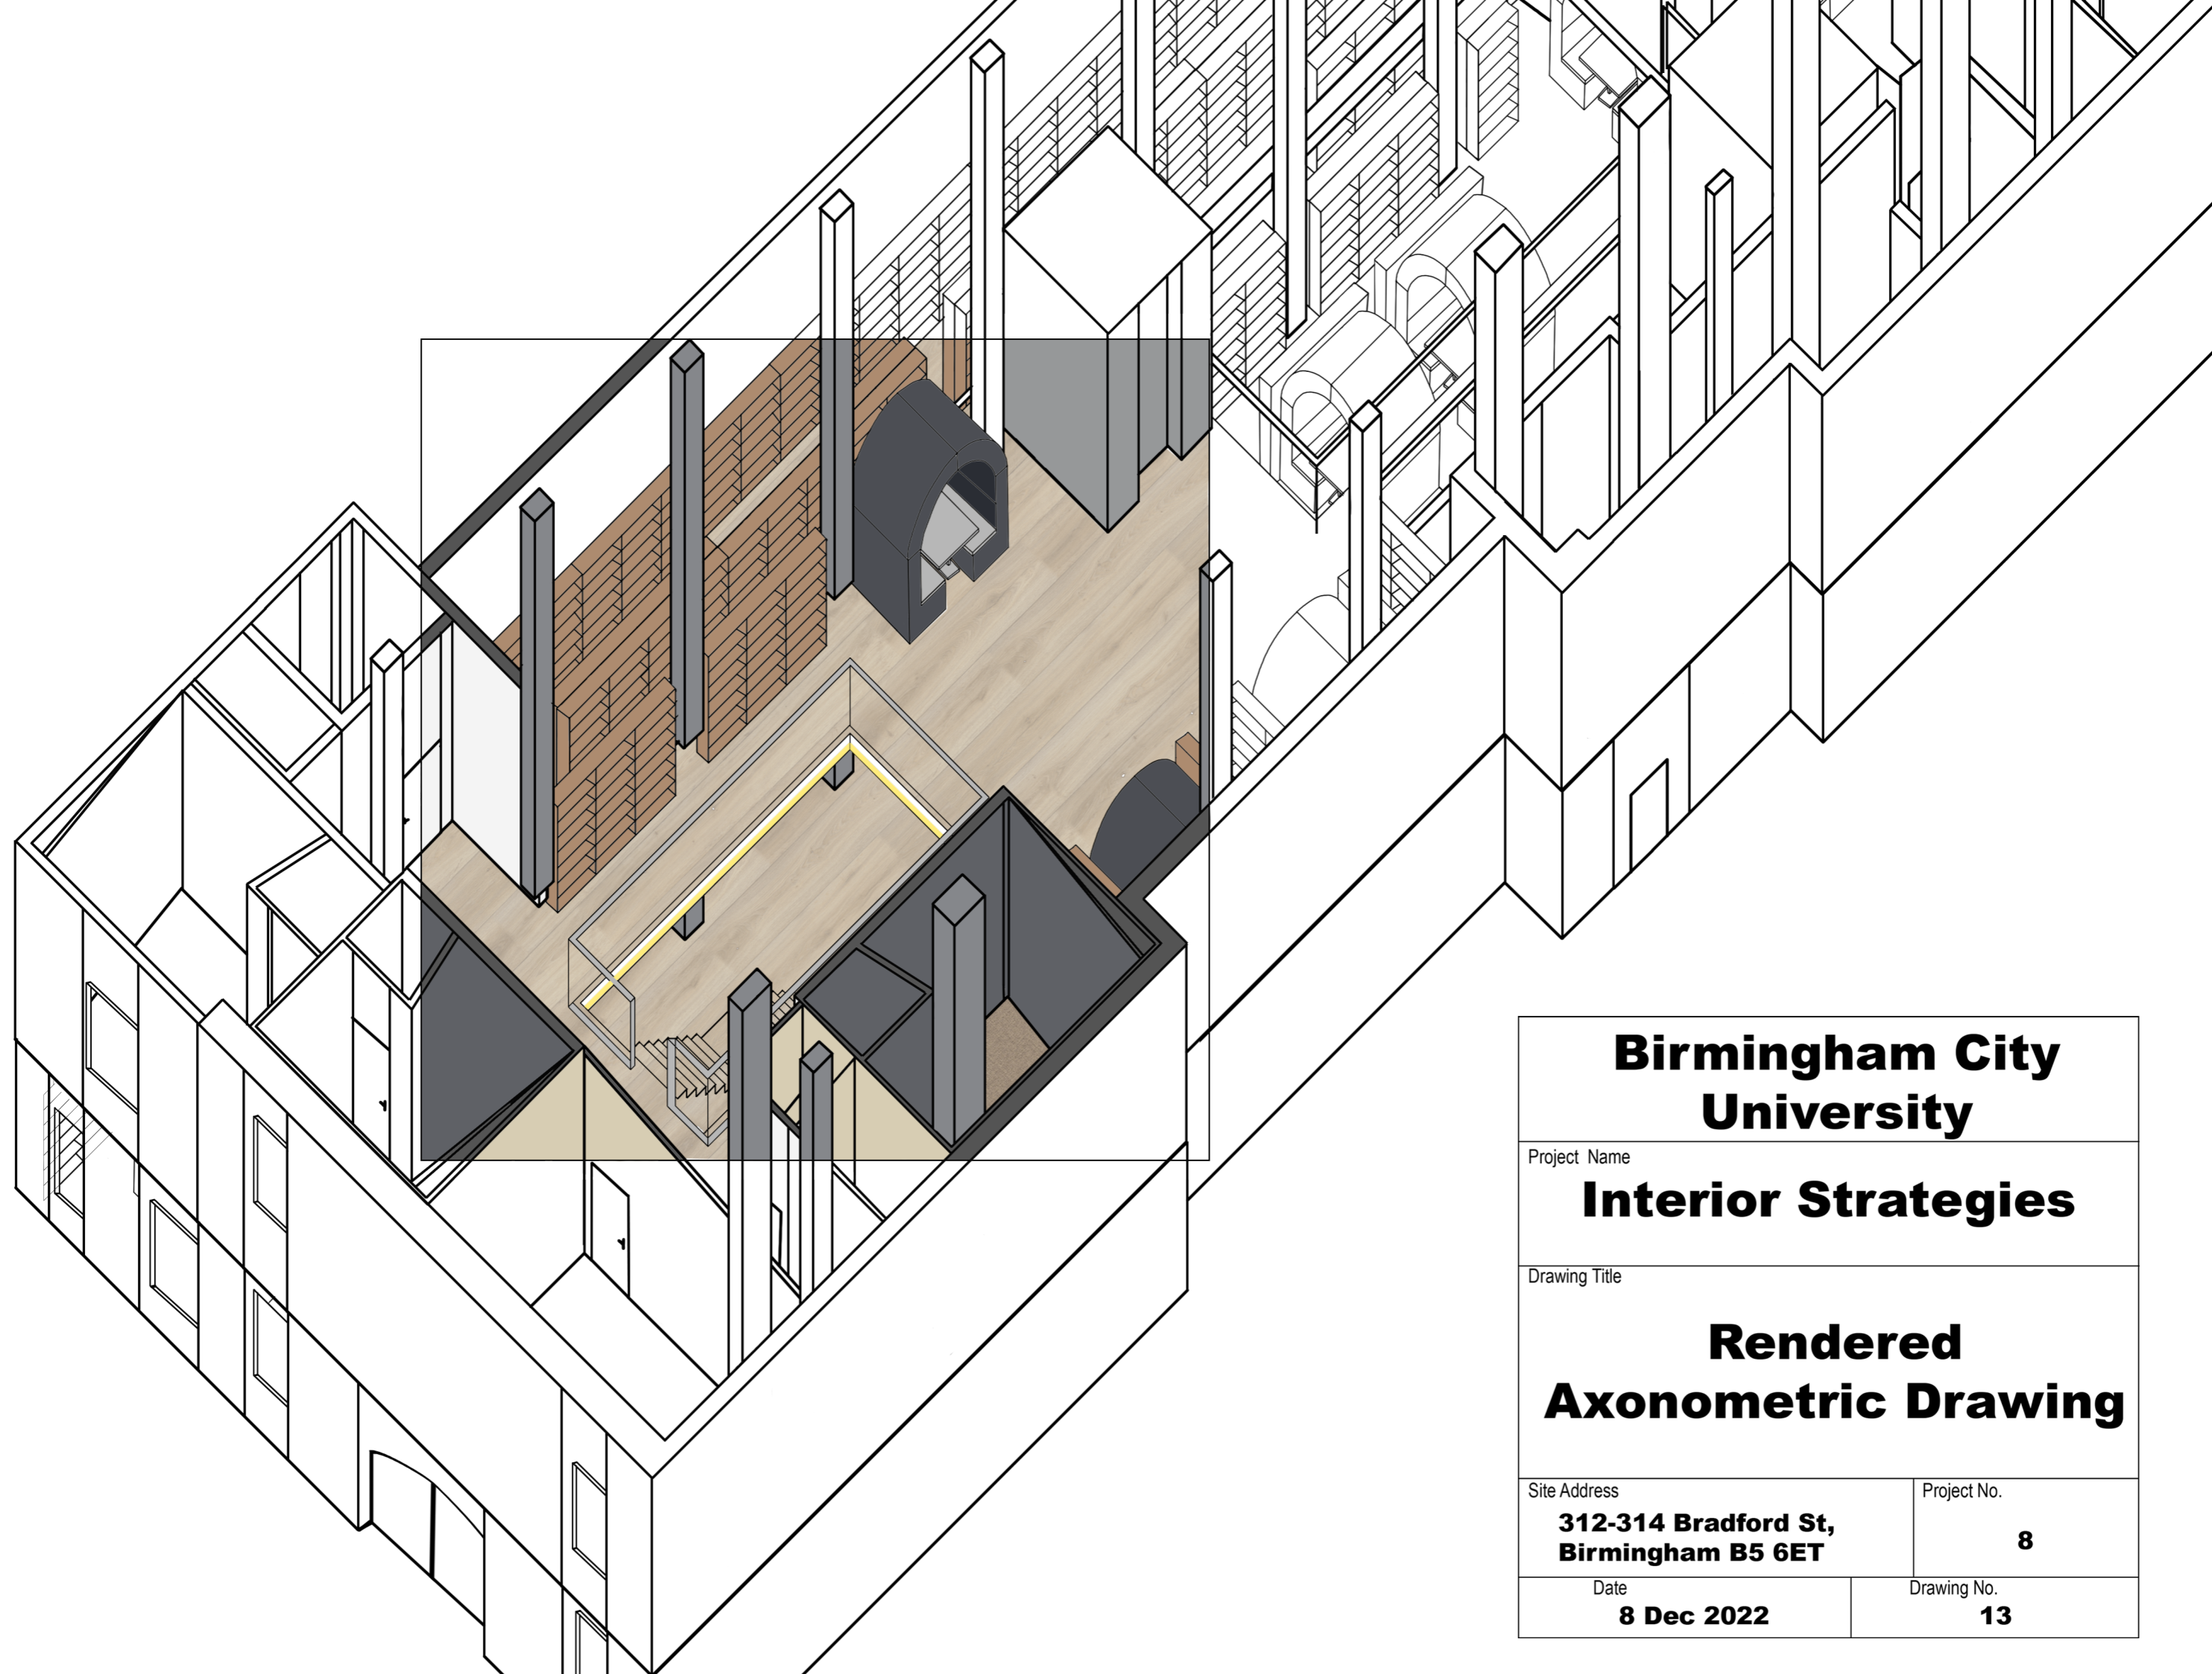

**Birmingham City
University**

Project Name

Interior Strategies

Drawing Title

**Rendered
Axonometric Drawing**

Site Address

**312-314 Bradford St,
Birmingham B5 6ET**

Project No.


8

Date

8 Dec 2022

Drawing No.

13

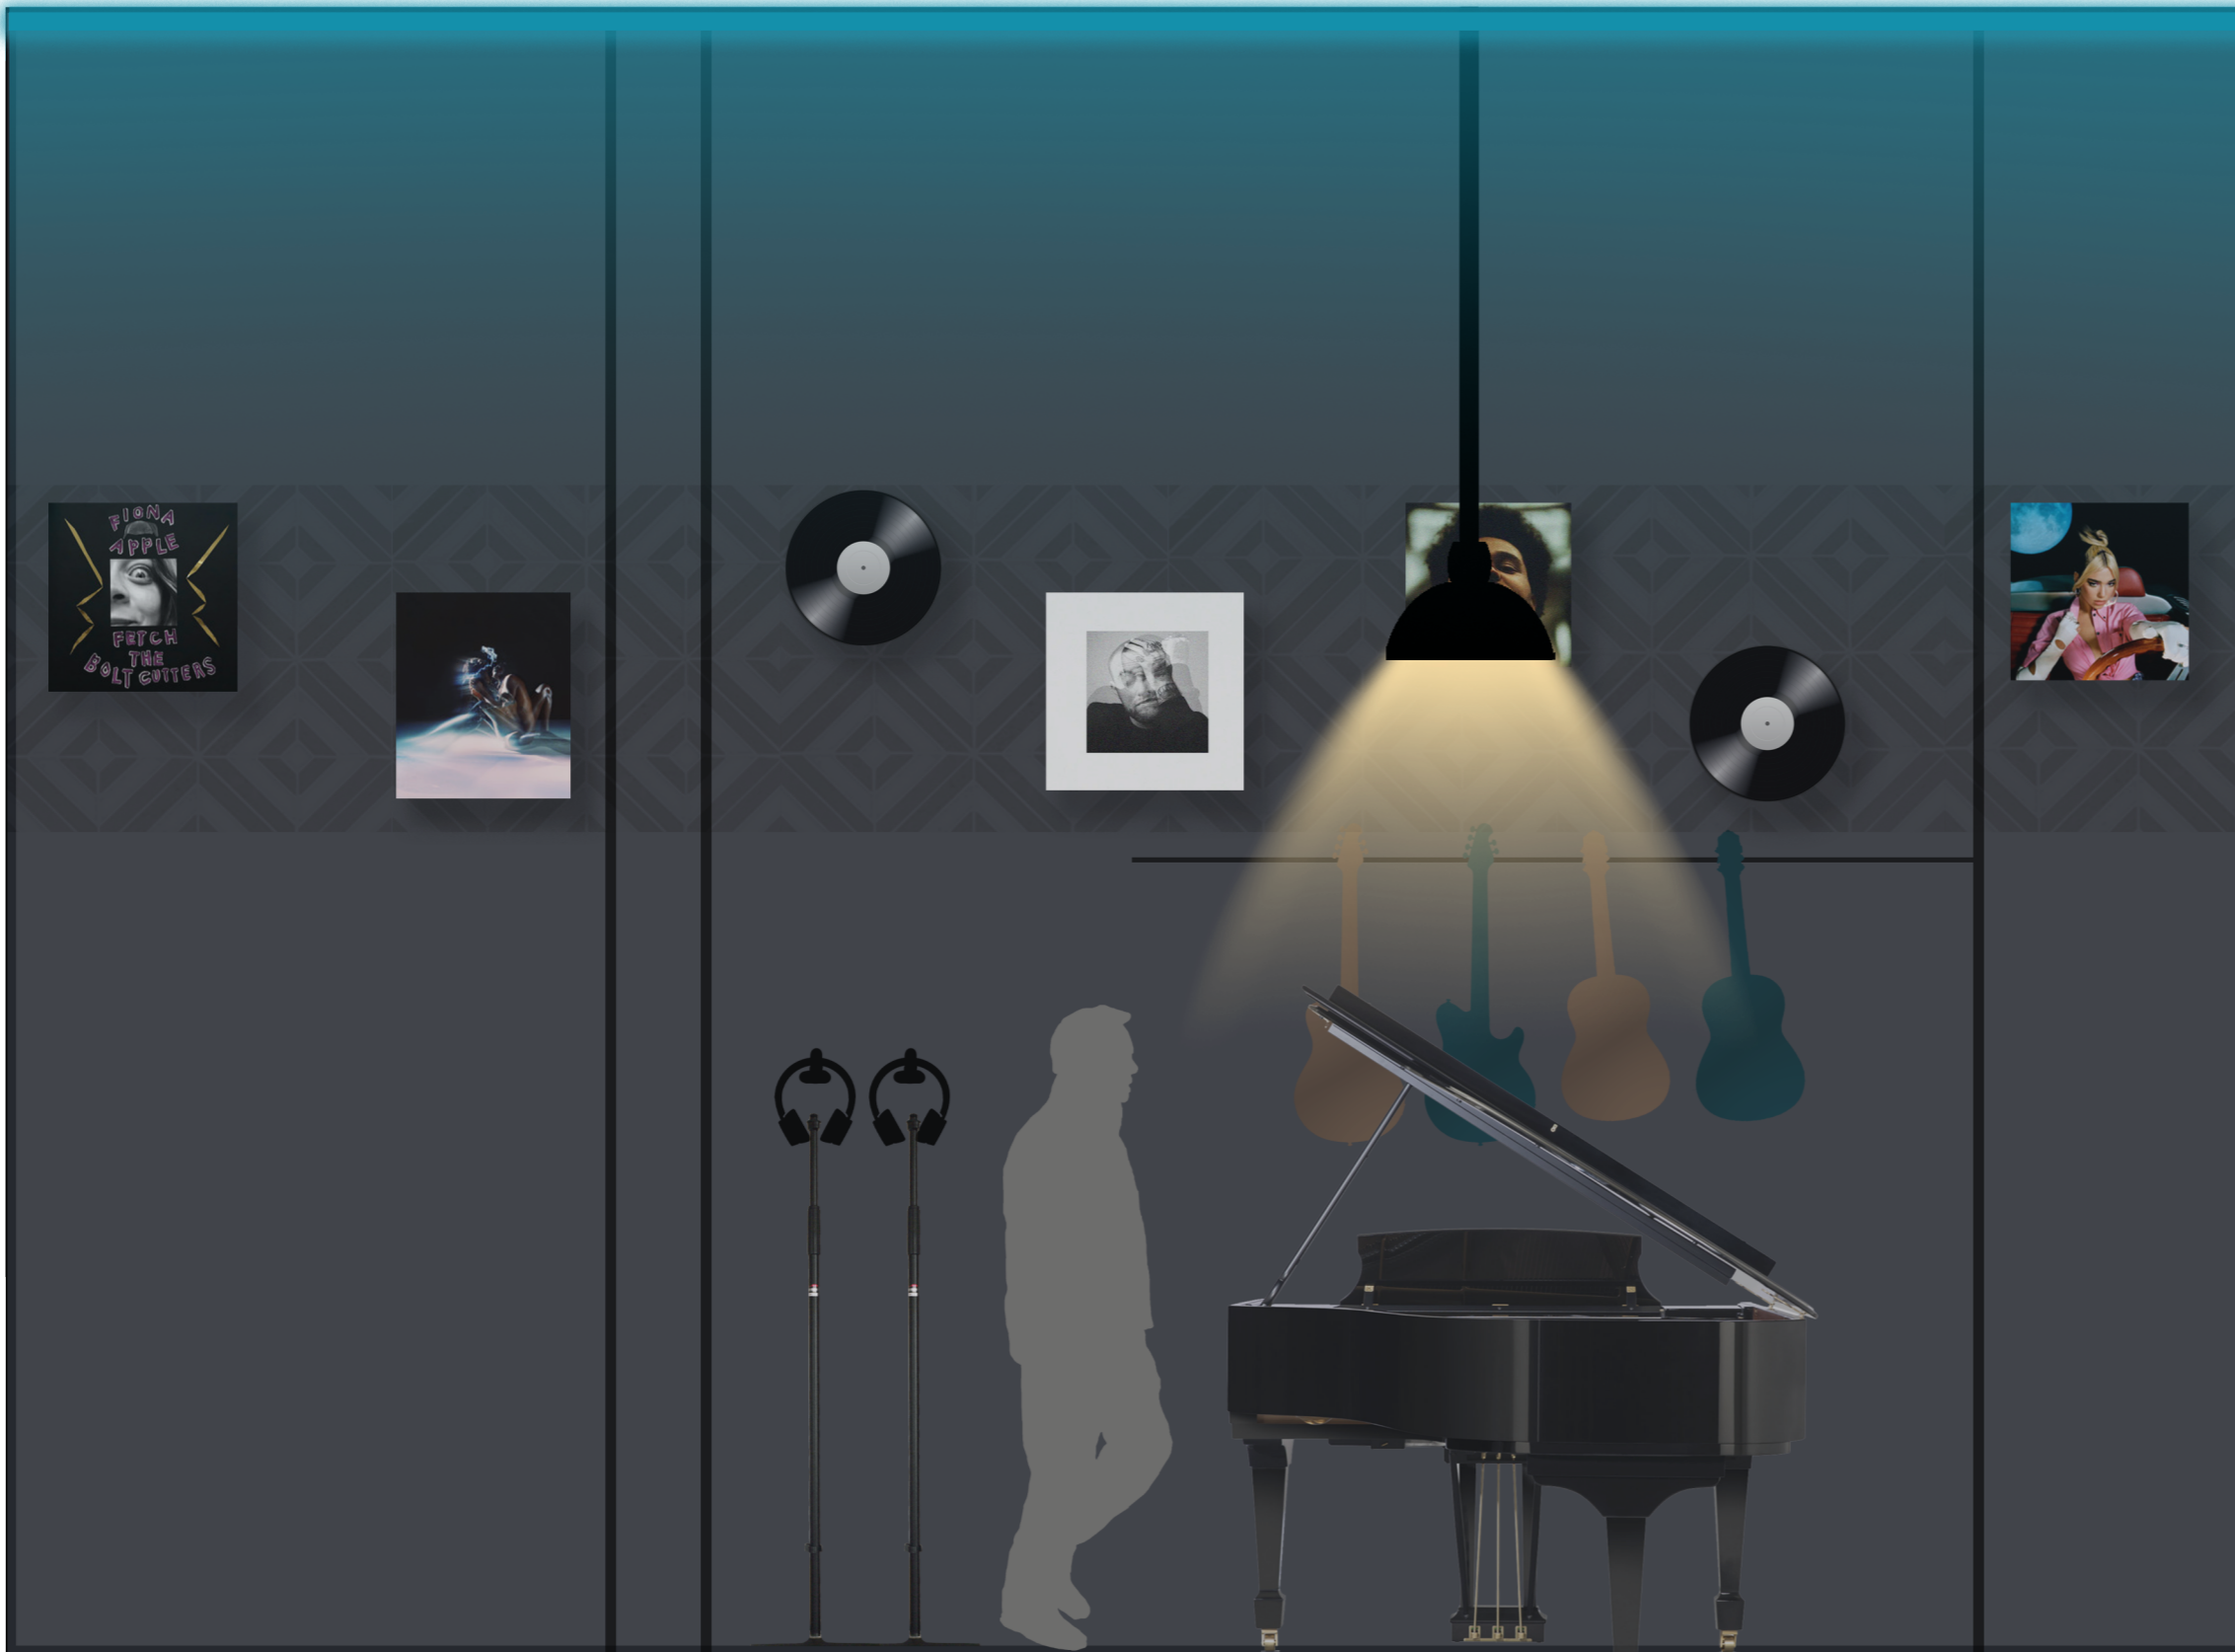

Birmingham City University

Project Name

Interior Strategies

Drawing Title

**Practise Room Layout
Render**

Site Address

**312-314 Bradford St,
Birmingham B5 6ET**

Project No.

8

Date

8 Dec 2022

Drawing No.

14